
 


ALL DIMENSIONS IN mm







A					TITLE G125RS T4F DSE7310 CONTROL SCHEMATIC CLASSIFIED IN SCHEMATIC		DRAWING NO.		JCB POWER PRODUCTS A2						
							401/K4259								
							SCALE: NOT TO SCALE		SHEET 1 OF 5		© JCB POWER PRODUCTS LIMITED ROCESTER, STAFFORDSHIRE, UK ST14 5JP CONFIDENTIAL INFORMATION - NOT TO BE COPIED WITHOUT WRITTEN CONSENT				
1		2		3		4		5		6			7		8

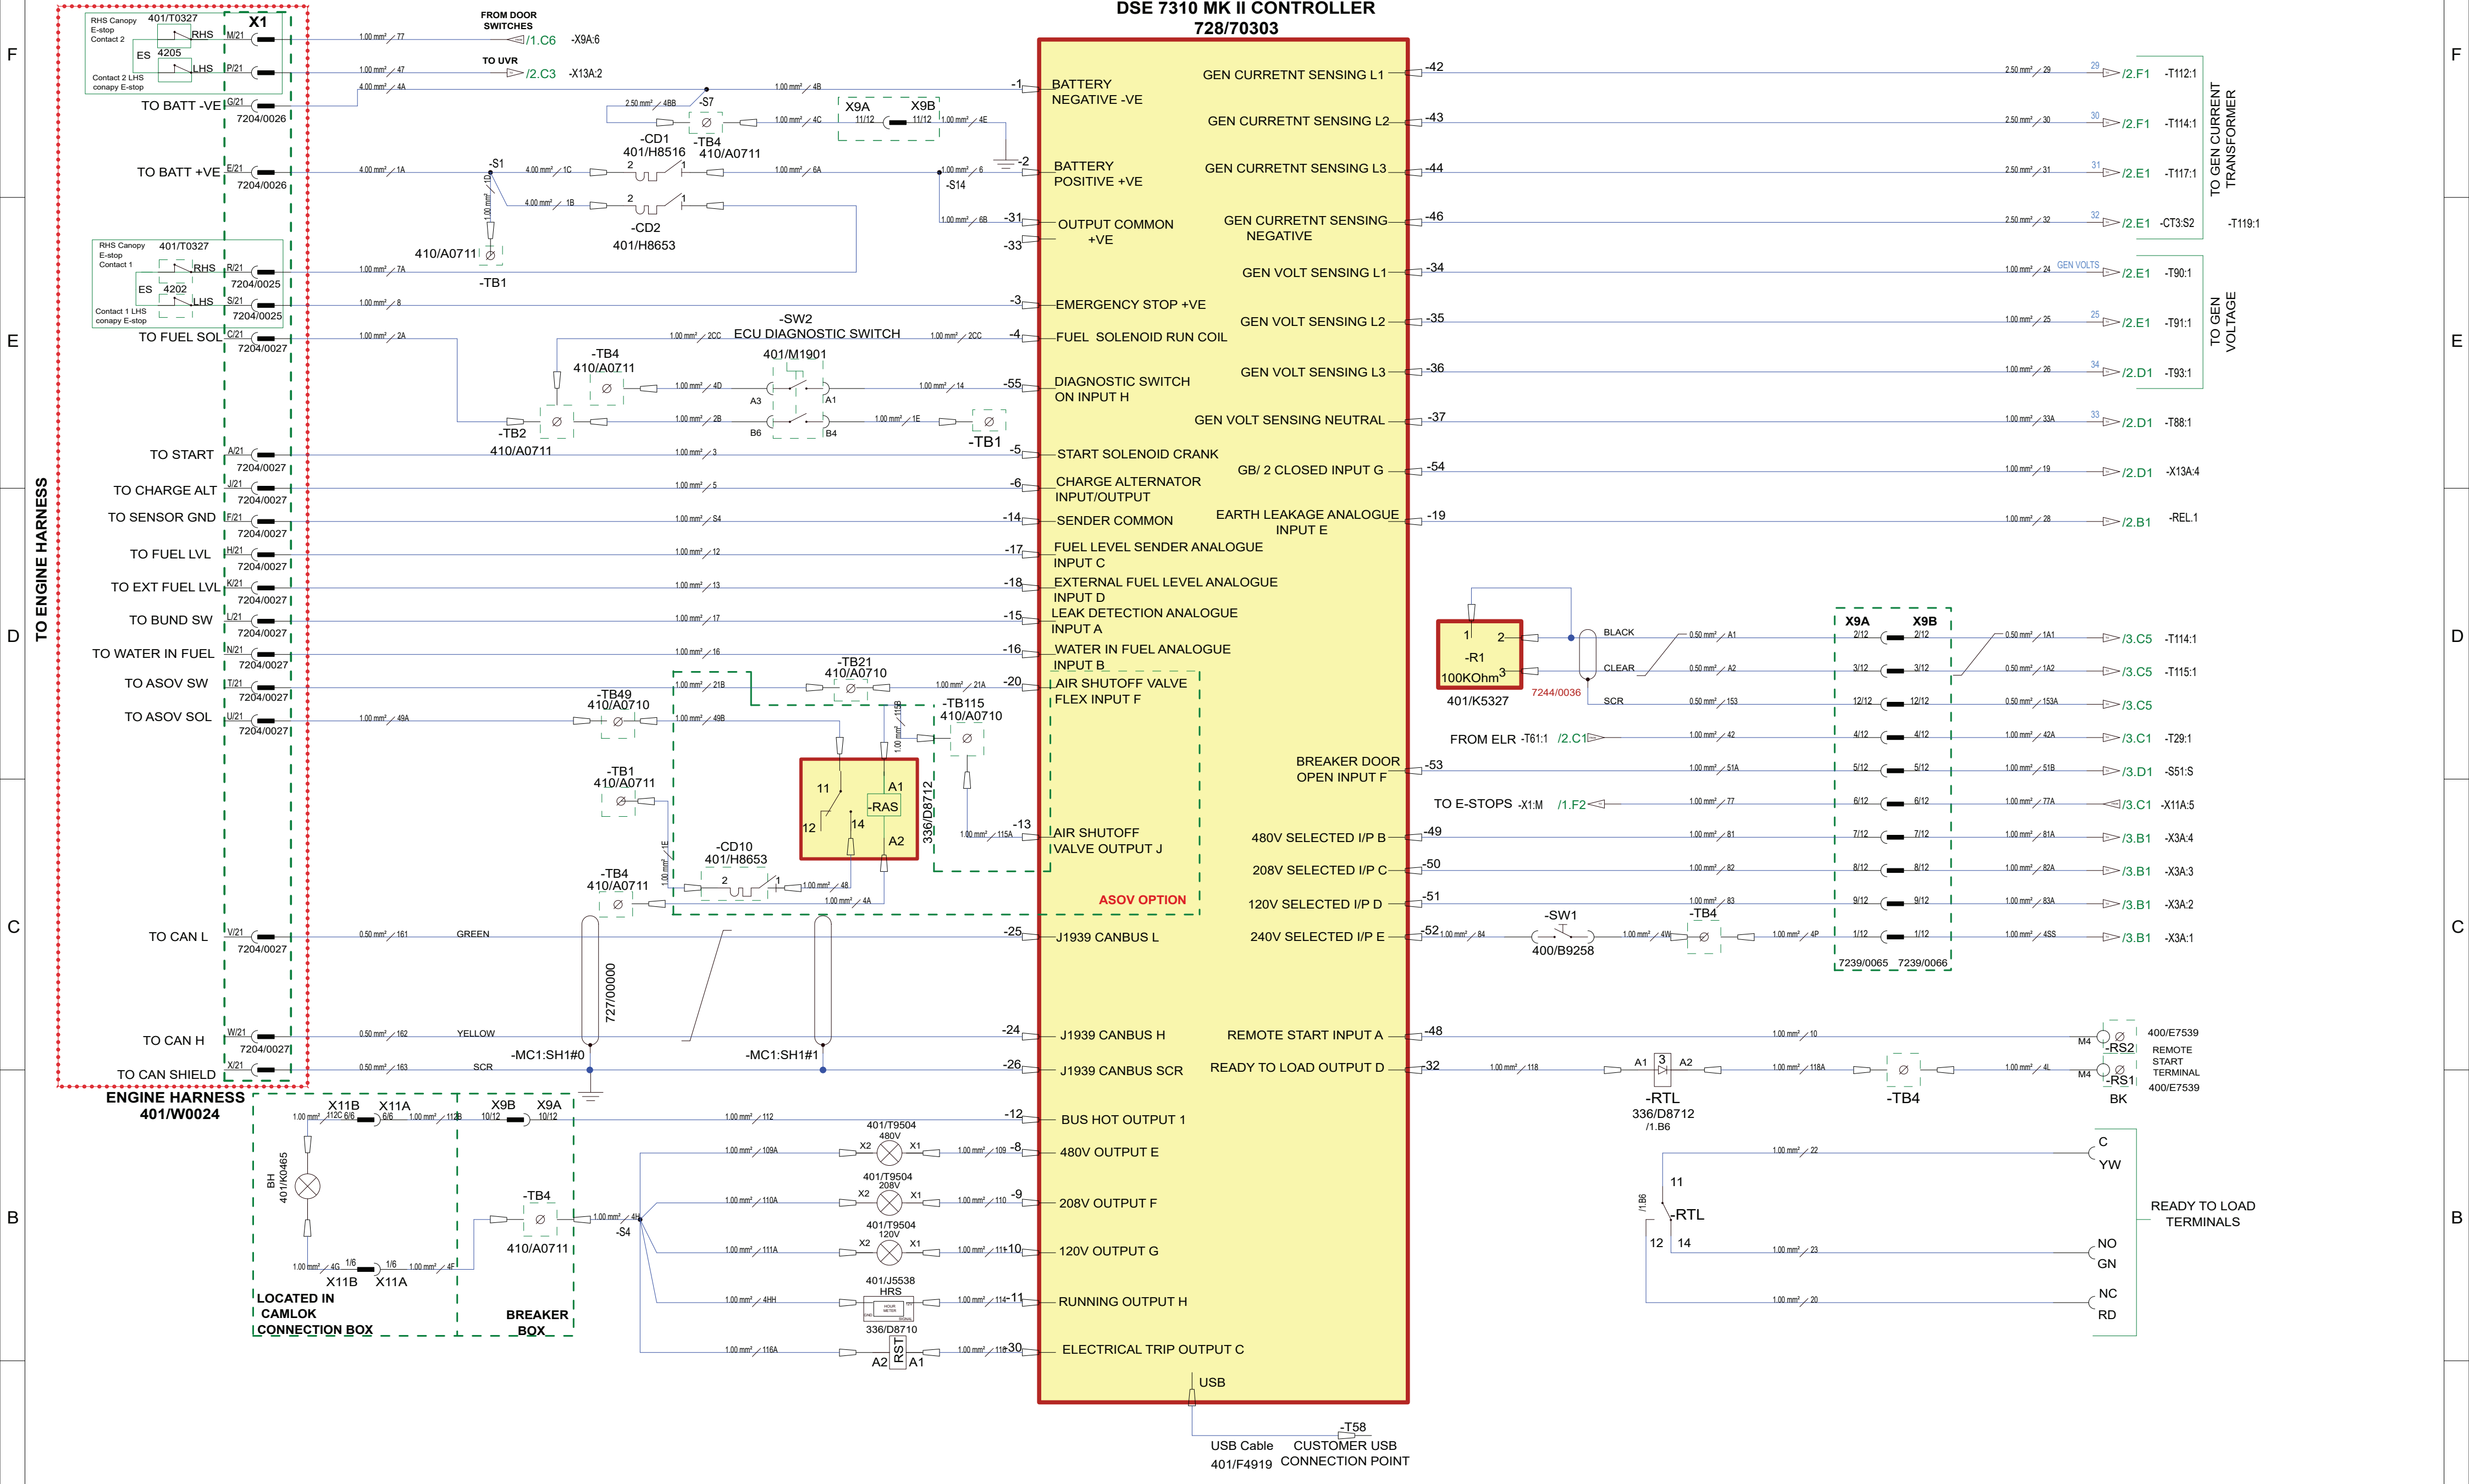



ALL DIMENSIONS IN mm

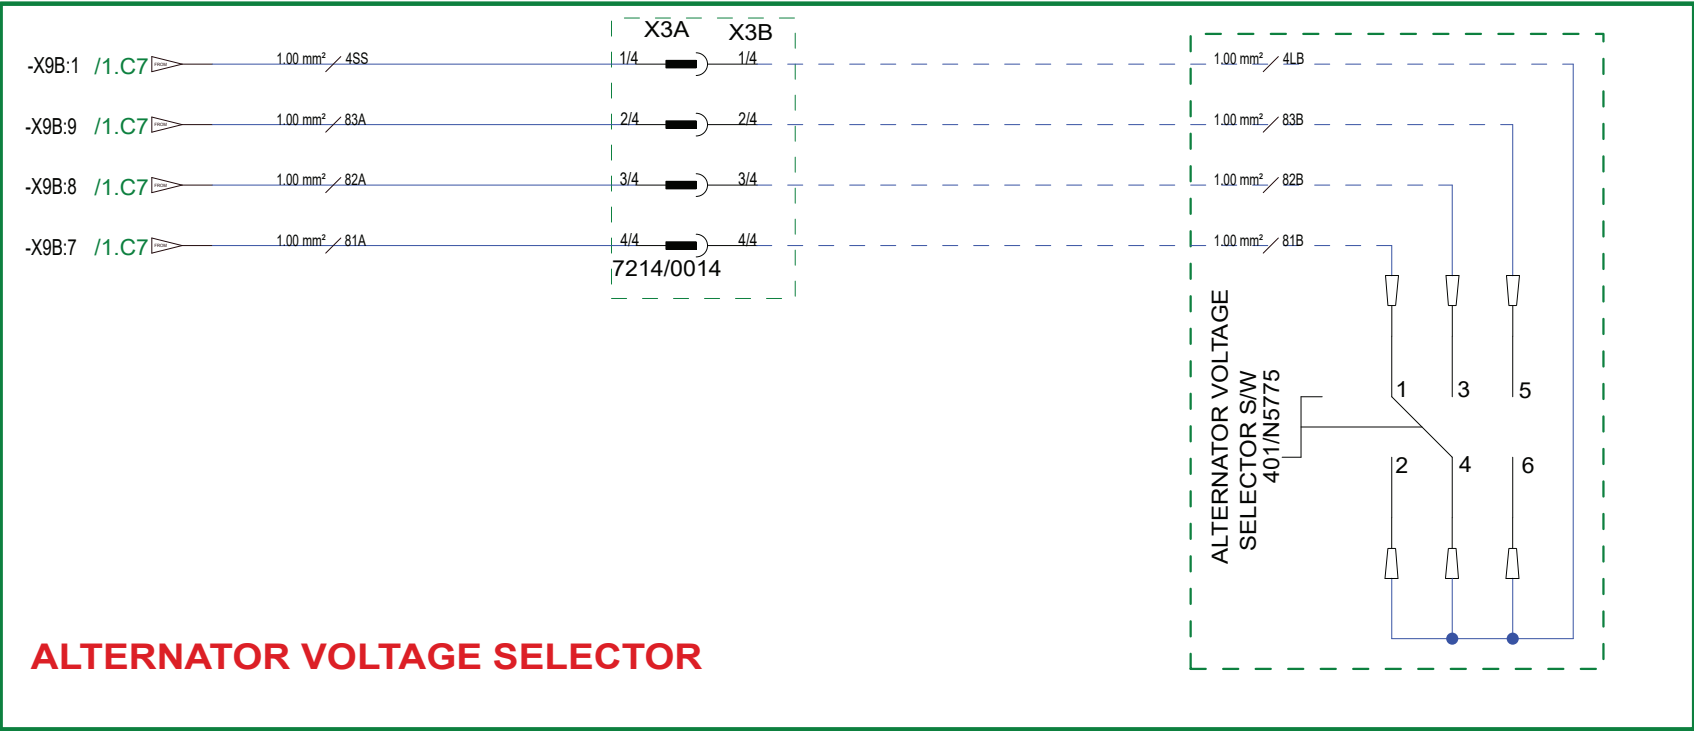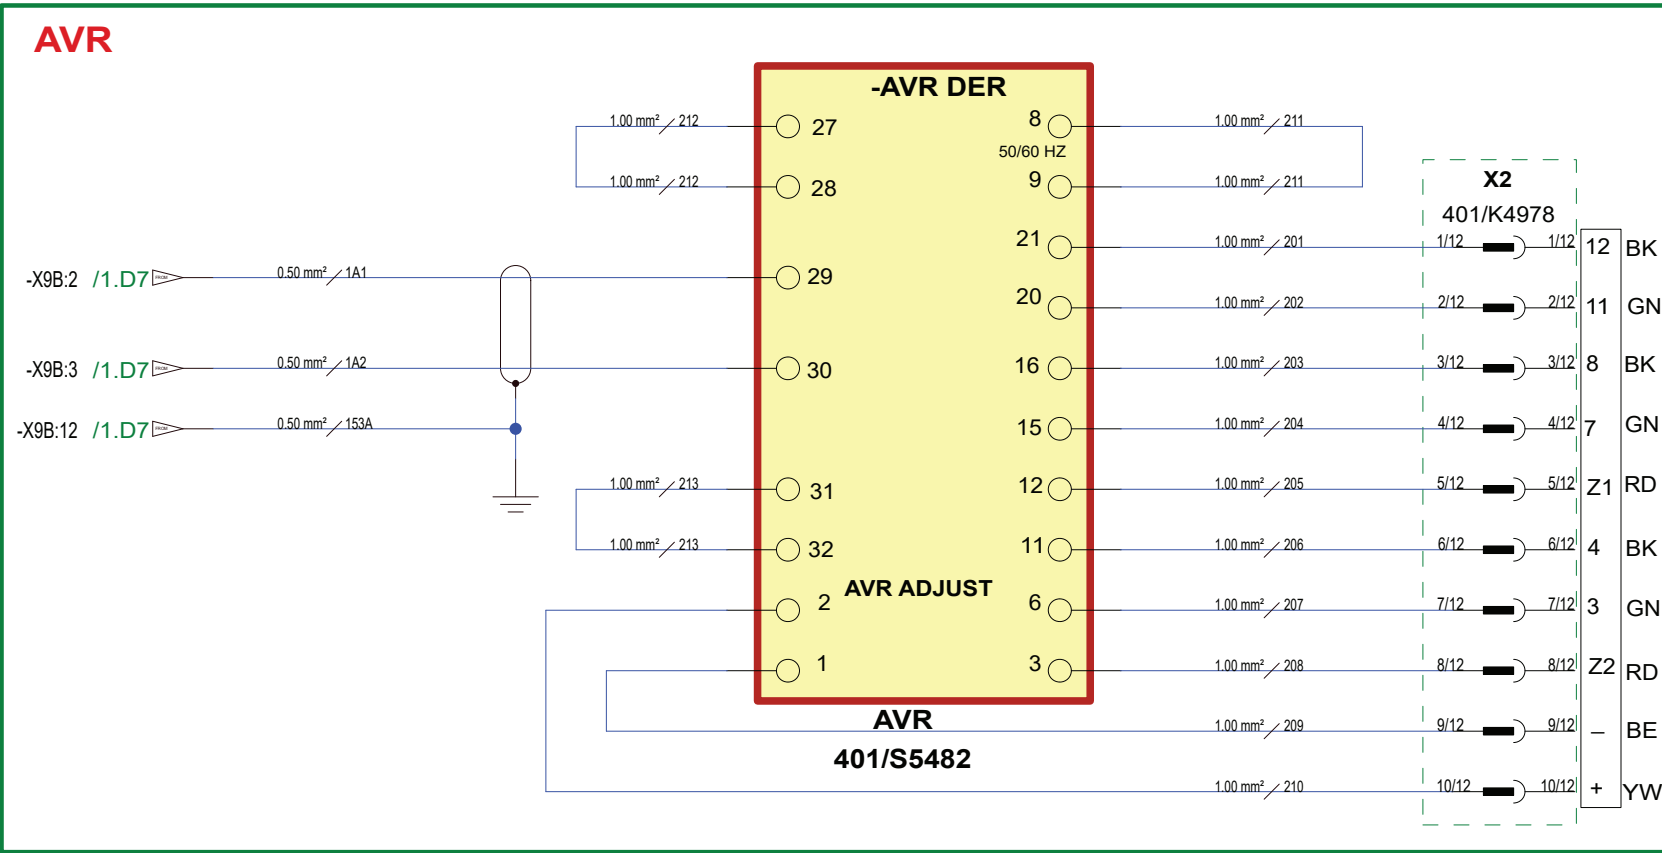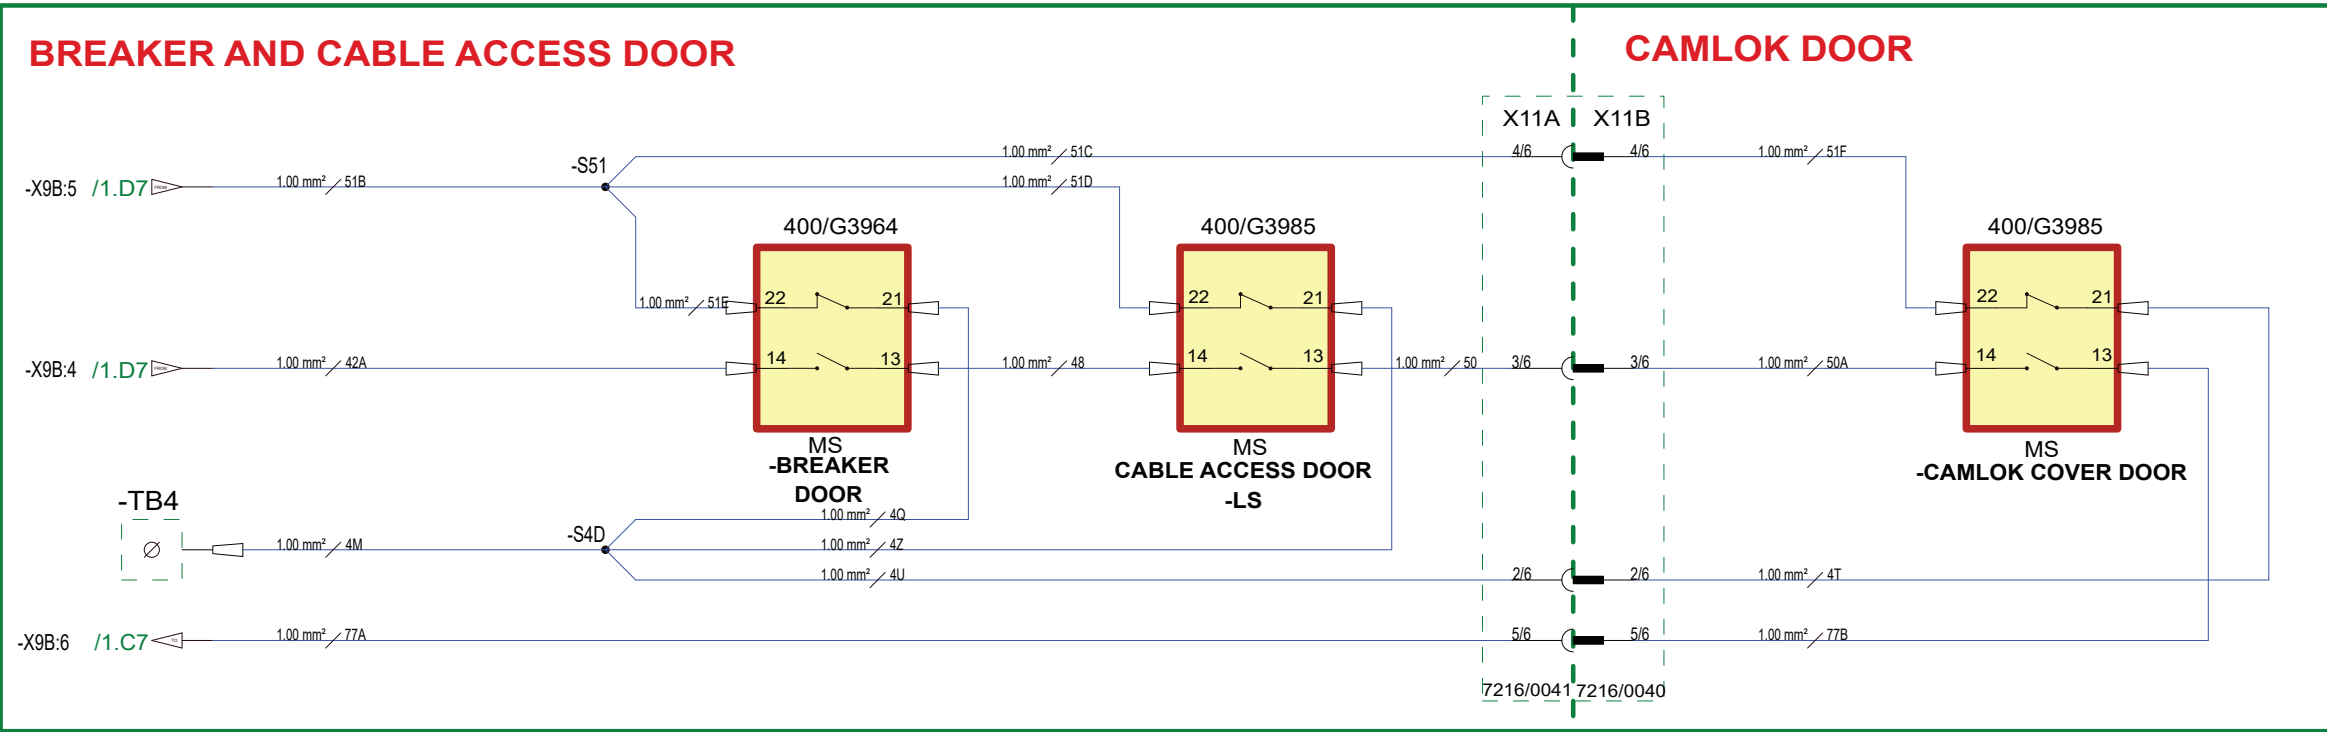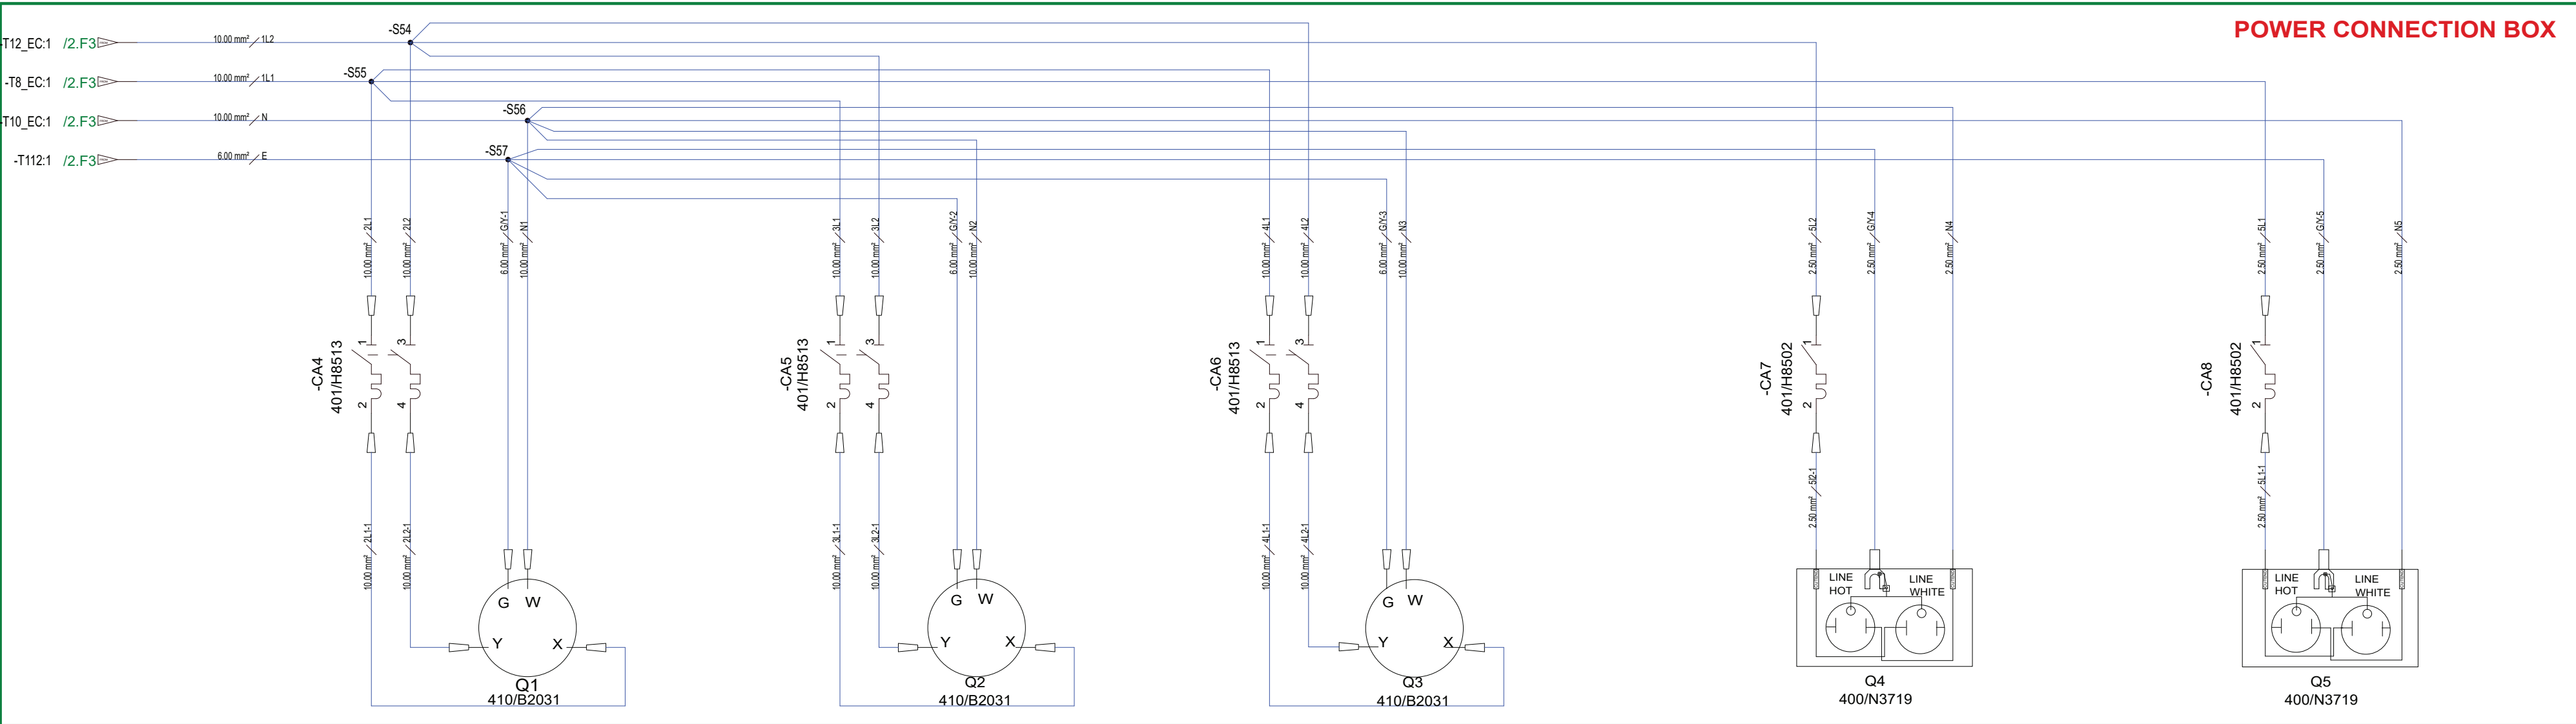

TITLE
G125RS T4F
DSE7310 CONTROL SCHEMATIC
CLASSIFIED IN SCHEMATIC

DRAWING NO.

401/K4259

 
SCALE: NOT TO SCALE

SHEET 3 OF 5




© JCB POWER PRODUCTS LIMITED
ROCESTER, STAFFORDSHIRE, UK ST14 5JP
CONFIDENTIAL INFORMATION - NOT TO BE COPIED WITHOUT WRITTEN CONSENT

A2



ALL DIMENSIONS IN mm

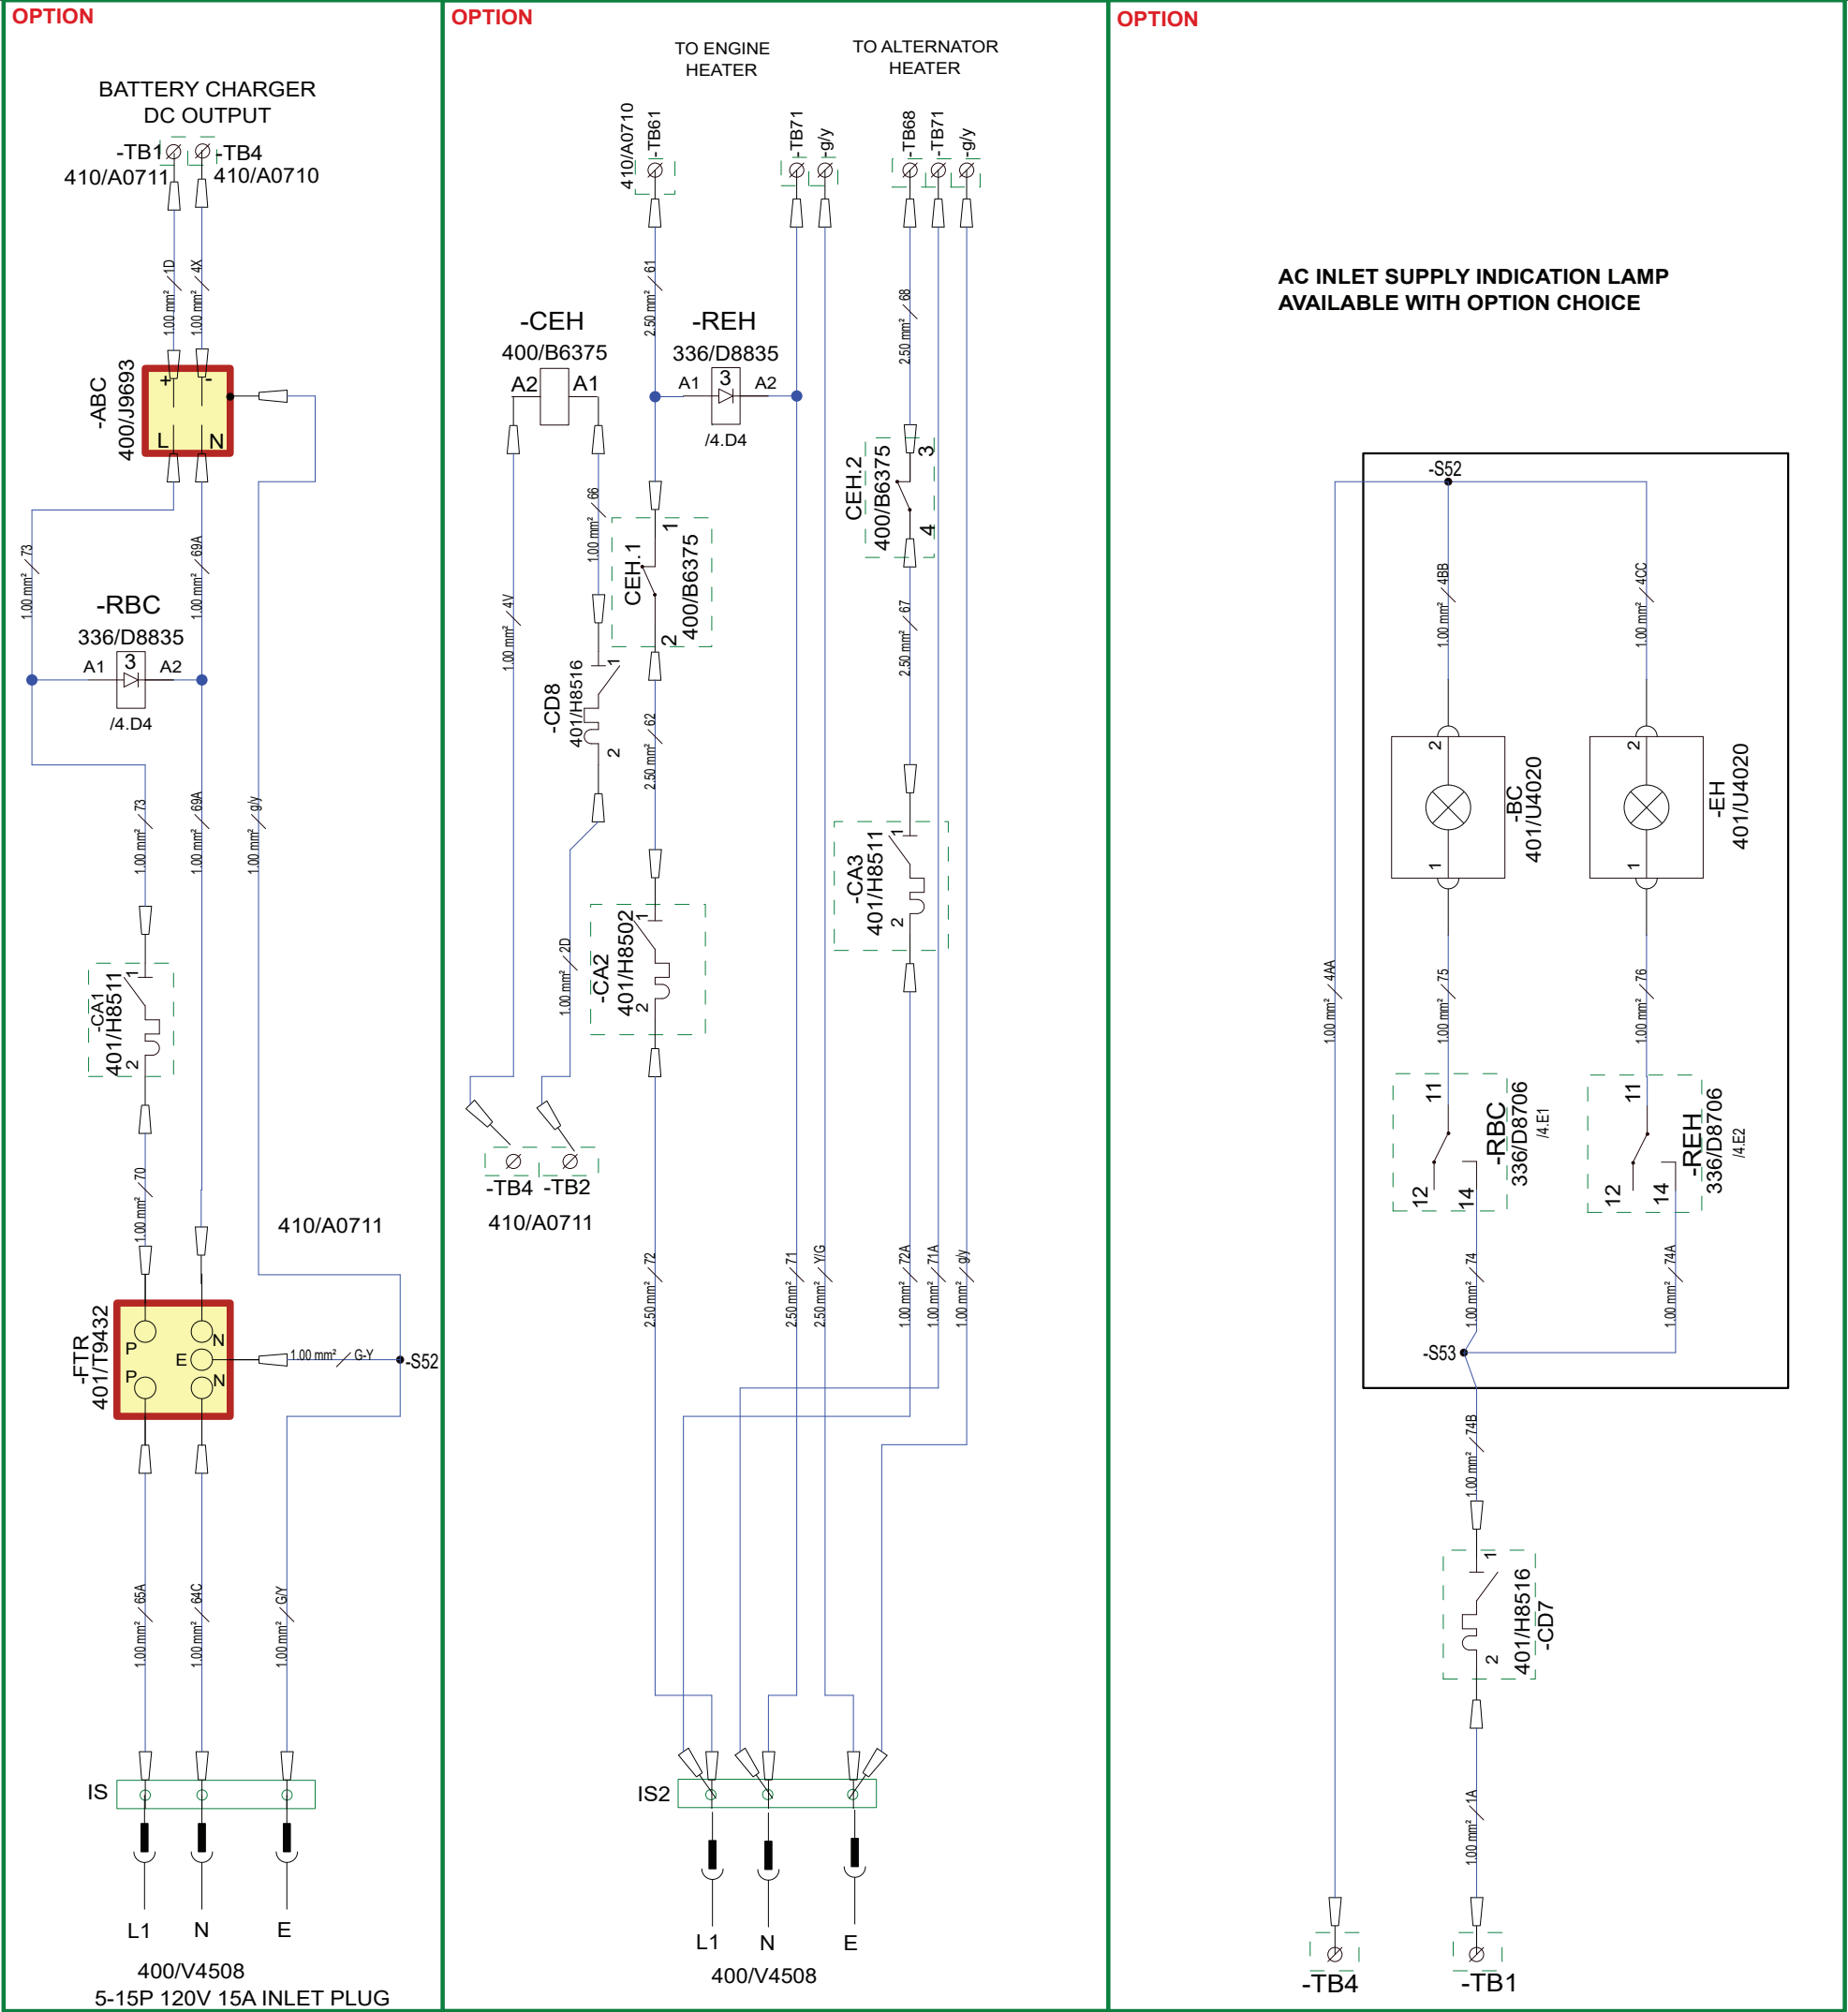

CABLE SIZE: 1MM
UNLESS OTHERWISE STATED

CABLE COLOURS
DC CONTROL: YELLOW

AC POWER SINGLE PHASE :LIVE BLACK
NEUTRAL WHITE
AC POWER THREE PHASE: L1 BLACK
L2 RED, L3 BLUE, NEUTRAL WHITE
AC CONTROL: BLACK
CT WIRING : GREY

SYSTEM VOLTAGE: 12VDC / 120-480VAC

NOTE :
REFER TO LOOM DRAWINGS IN PLM FOR MORE DETAILS.

TITLE G125RS T4F DSE7310 CONTROL SCHEMATIC		DRAWING NO.		JCB POWER PRODUCTS A2
		401/K4259		
CLASSIFIED IN	SCHEMATIC	SHEET 4 OF 5		
SCALE: NOT TO SCALE				

